
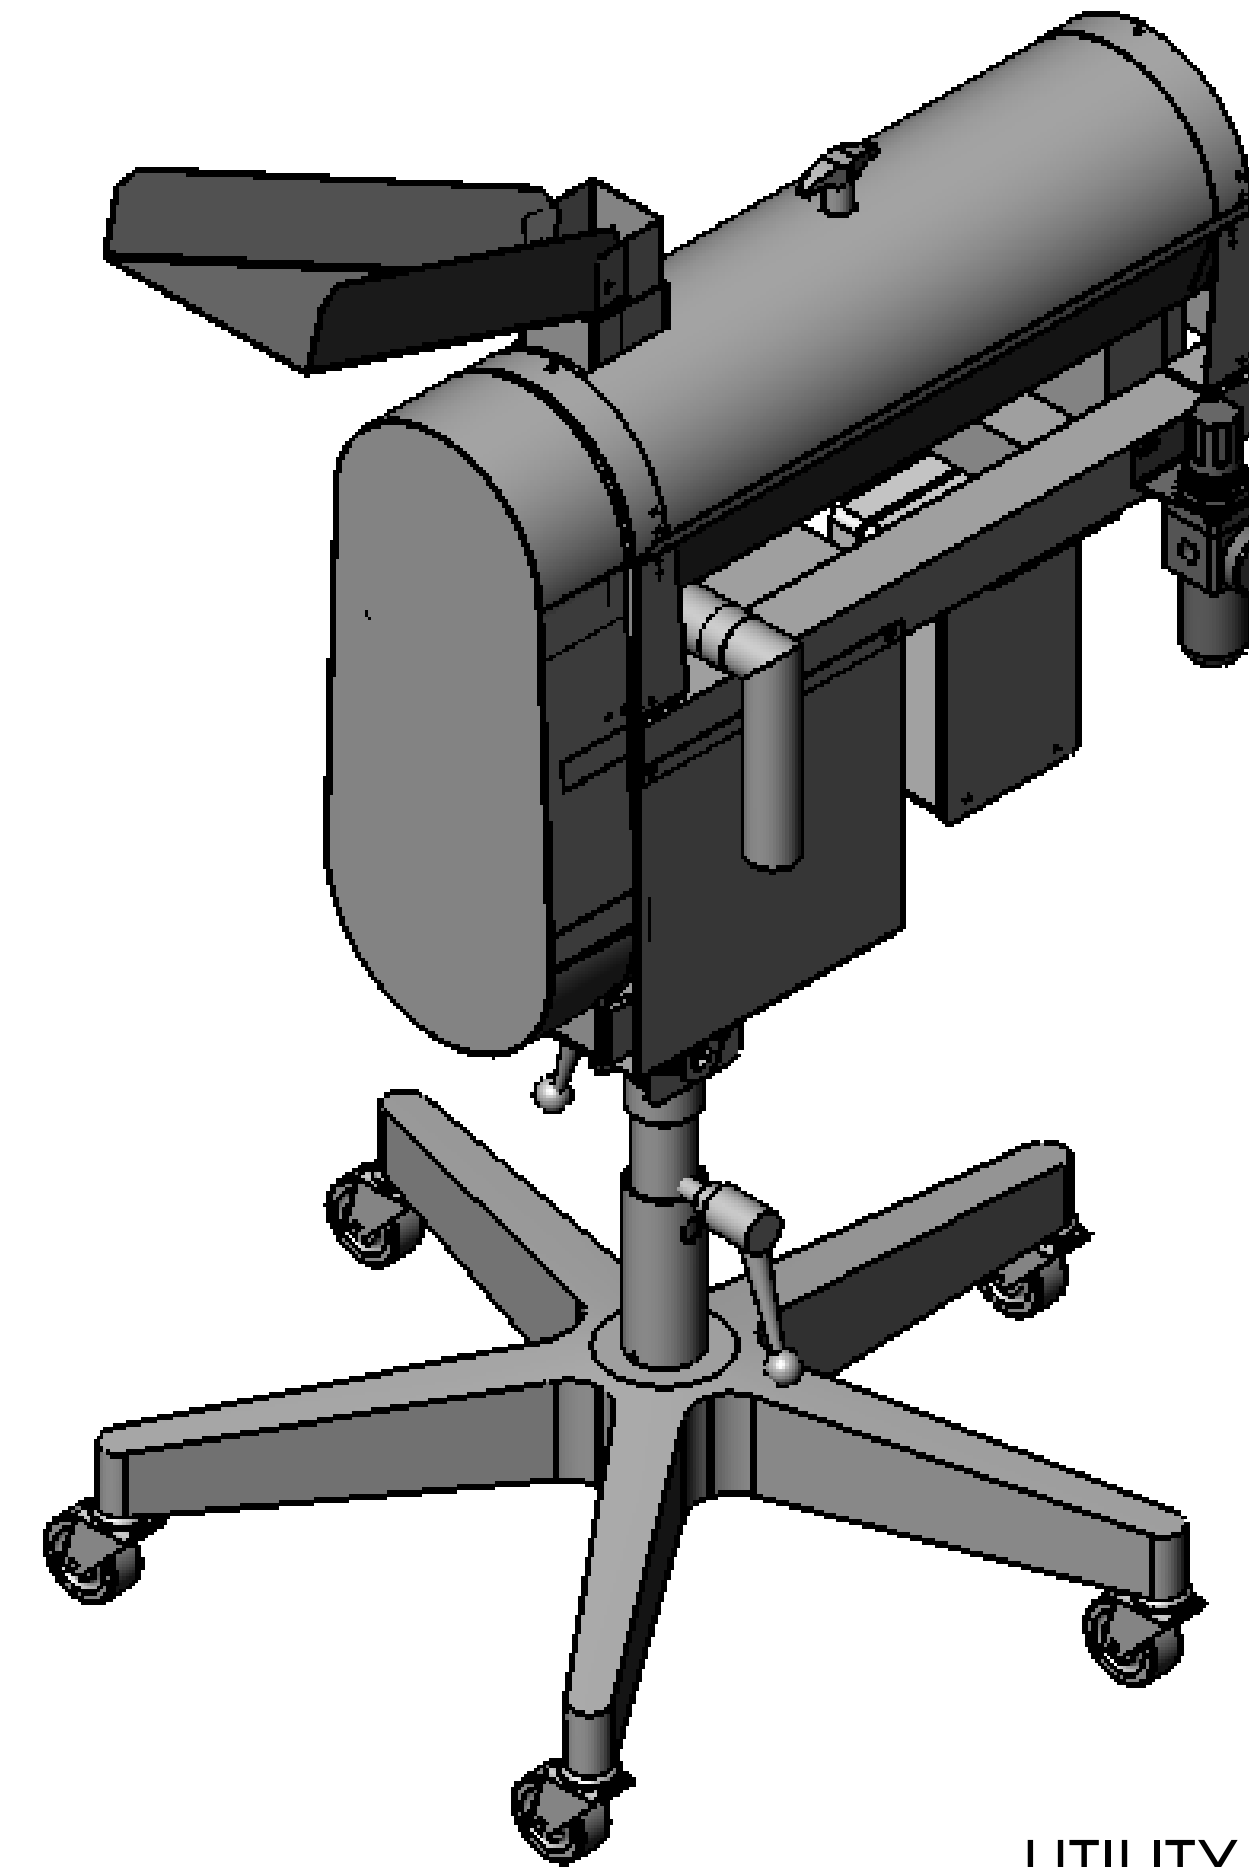


THE INFORMATION CONTAINED IN THIS DRAWING IS THE SOLE PROPERTY OF KEY INTERNATIONAL, INC. ANY REPRODUCTION IN PART OR WHOLE WITHOUT THE WRITTEN PERMISSION OF KEY INTERNATIONAL, INC. IS PROHIBITED.

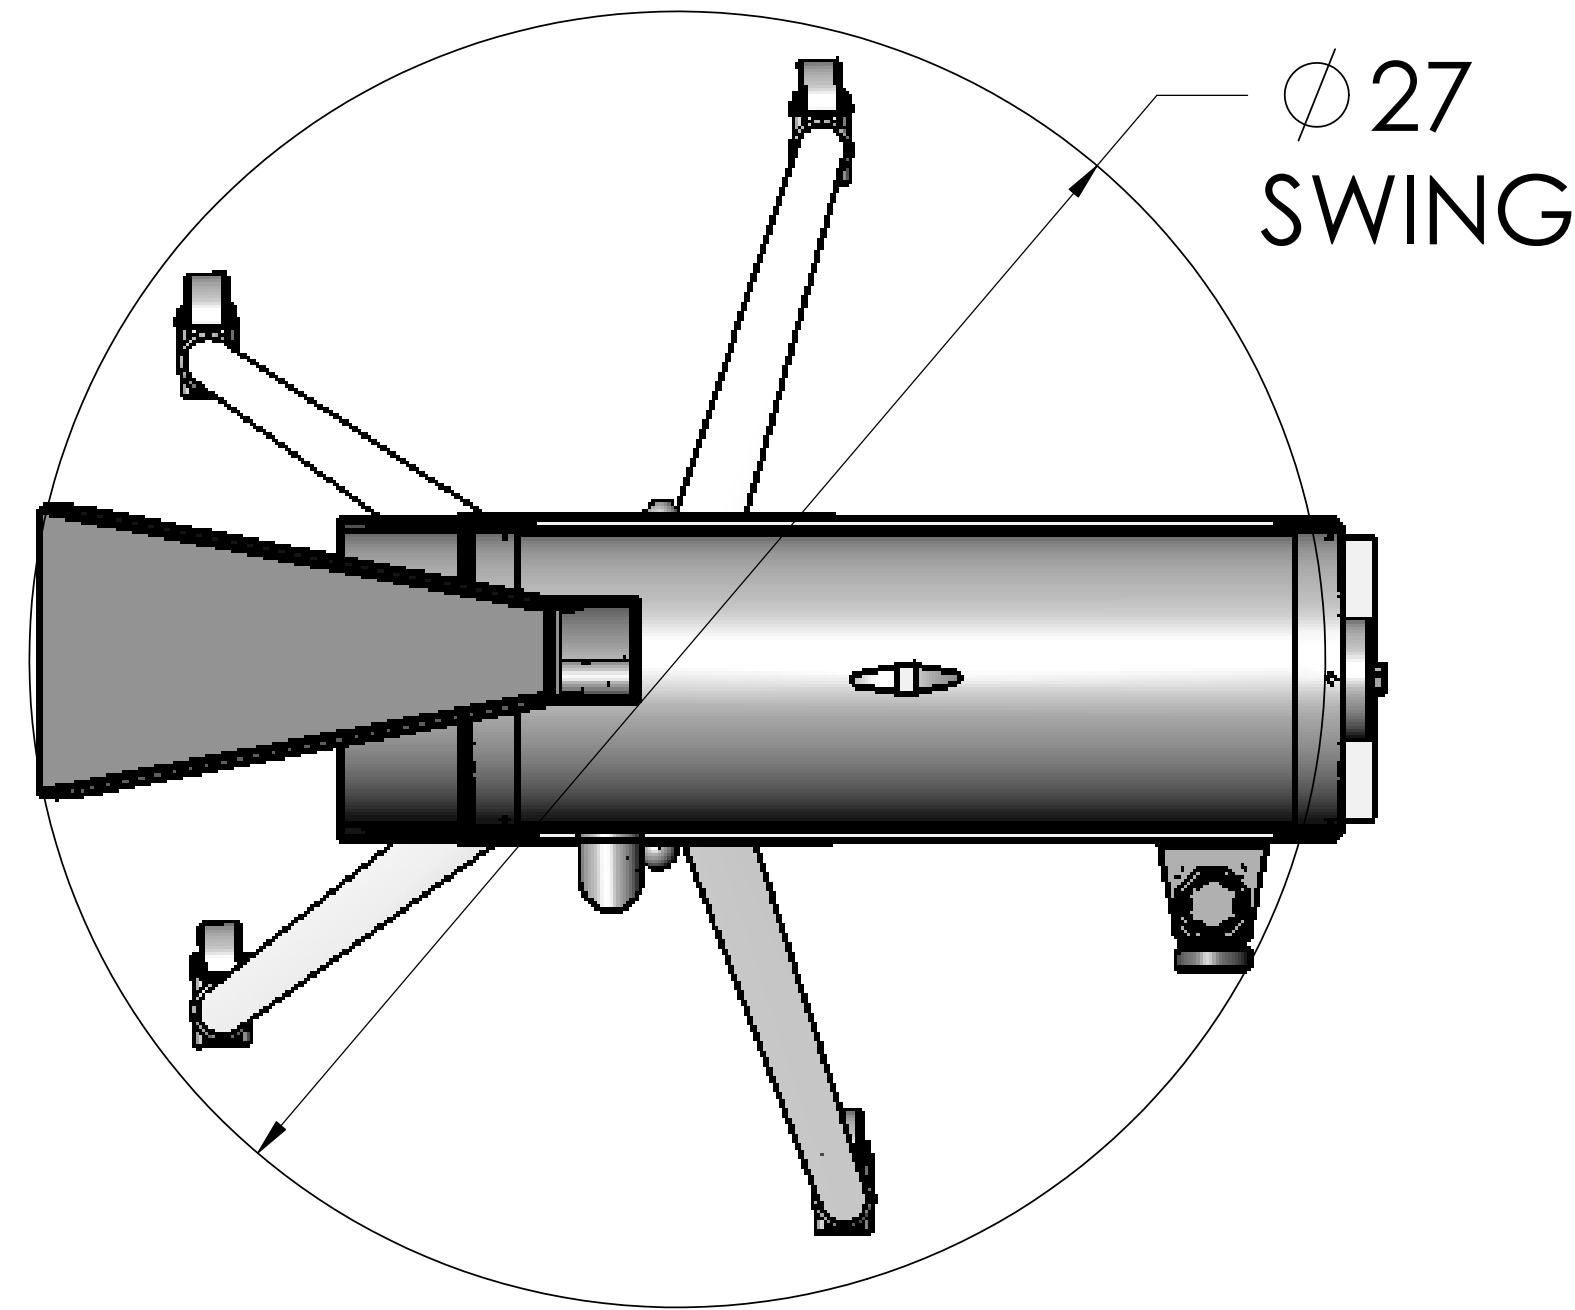

33 MIN.  
40 MAX.  
(INLET)

1 1/4" O.D. TUBE  
FOR VACUUM HOSE  
CONNECTION

ANGLE OF UNIT IS  
ADJUSTABLE FROM 0 TO 30°  
FROM POSITION SHOWN.

COMPRESSED AIR  
CONNECTION (1/4" NPT)

27 MIN.  
30 MAX.  
(DISCHARGE)

UTILITY REQUIREMENTS

- \* ELECTRICAL, 1/4 HP D/C MOTOR AND CONTROL, NEMA 4 (WASHDOWN)  
110 V/1PH/60HZ, 4.0 FULL LOAD AMPS
- \* AIR, 1.5 TO 3.0 CFM, OIL FREE, SANITARY
- \* VACUUM, 25 TO 50 CFM @ 3" H2O S.P.
- \* WEIGHT, 55 LBS. NET

REV.	BY	DATE	DESCRIPTION OF CHANGE
* * * *			
CAD GENERATED DRAWING DO NOT MANUALLY UPDATE UNLESS OTHERWISE SPECIFIED, DIMENSIONS ARE IN INCHES. TOLERANCES ARE: FRACTIONAL = +/- 1/64 DECIMAL (2-PLACES) = +/- .015 DECIMAL (3-PLACES) = +/- .005 ANGULAR = +/- 1 deg.			<b>KEY INTERNATIONAL, INC.</b> <b>480 ROUTE 9</b> <b>ENGLISHTOWN, NJ 07726</b>
WHERE USED:			TITLE: <b>FLOOR PLAN, CP-350 CAPSULE POLISHER</b>
DRAWN: <b>JPC</b>	SCALE:		DWG. No. <b>CP-350-0000D</b>
DATE: *	DO NOT SCALE		REV. *